


TILE/CULVERT LOCATIONS
 SCALES:
 1" = 400' HOR
 1" = 4' VER

mb
 Nielsen Madsen & Barber S.C.
 Civil Engineers and Land Surveyors
 1339 Washington Ave. Racine, WI. 53403
 Tele: (262)634-5588 Fax: (262)634-5024
 Website www.nmbcsc.net

DOVER / NORWAY DRAINAGE DISTRICT MAPPING DOVER DITCH PLAN AND PROFILE
 RACINE WISCONSIN


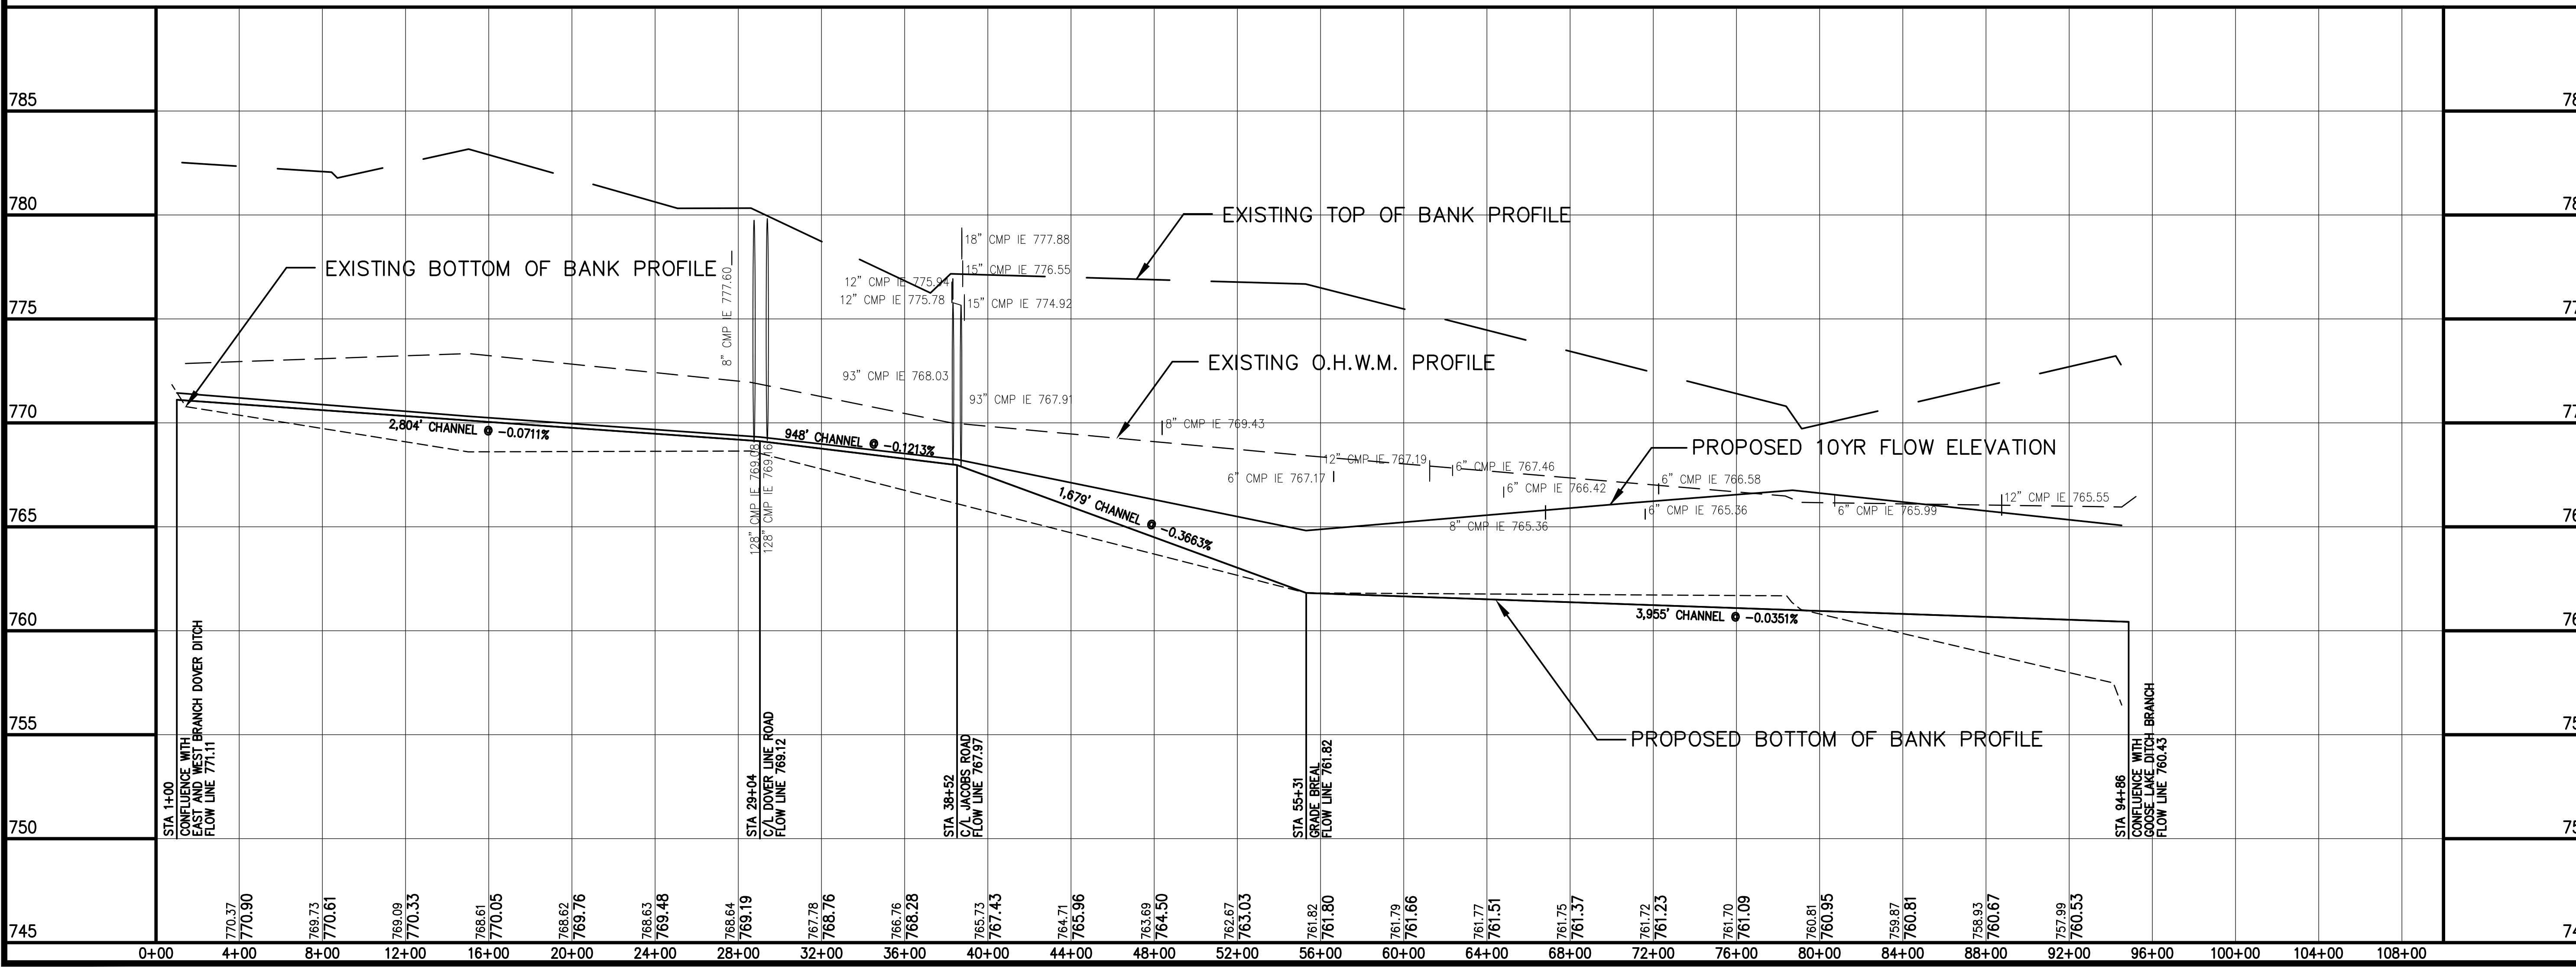


Thursday, June 13, 2024 8:42:42 AM

NO.	REVISION	BY	DATE
1	REVERSE ARROW DIRECTION TO REFLECT FLOW	SCB	11-18-10
2	UPDATE DISTRICT CORRIDORS	SCB	06-13-24

PROJ. MGR: MRM
 DRAFTED: SCB
 DATE: 6-15-2010
 CHECKED: JCB
 DATE: 6-15-2010


2010.0022.01
 SHEET
20 OF **83**

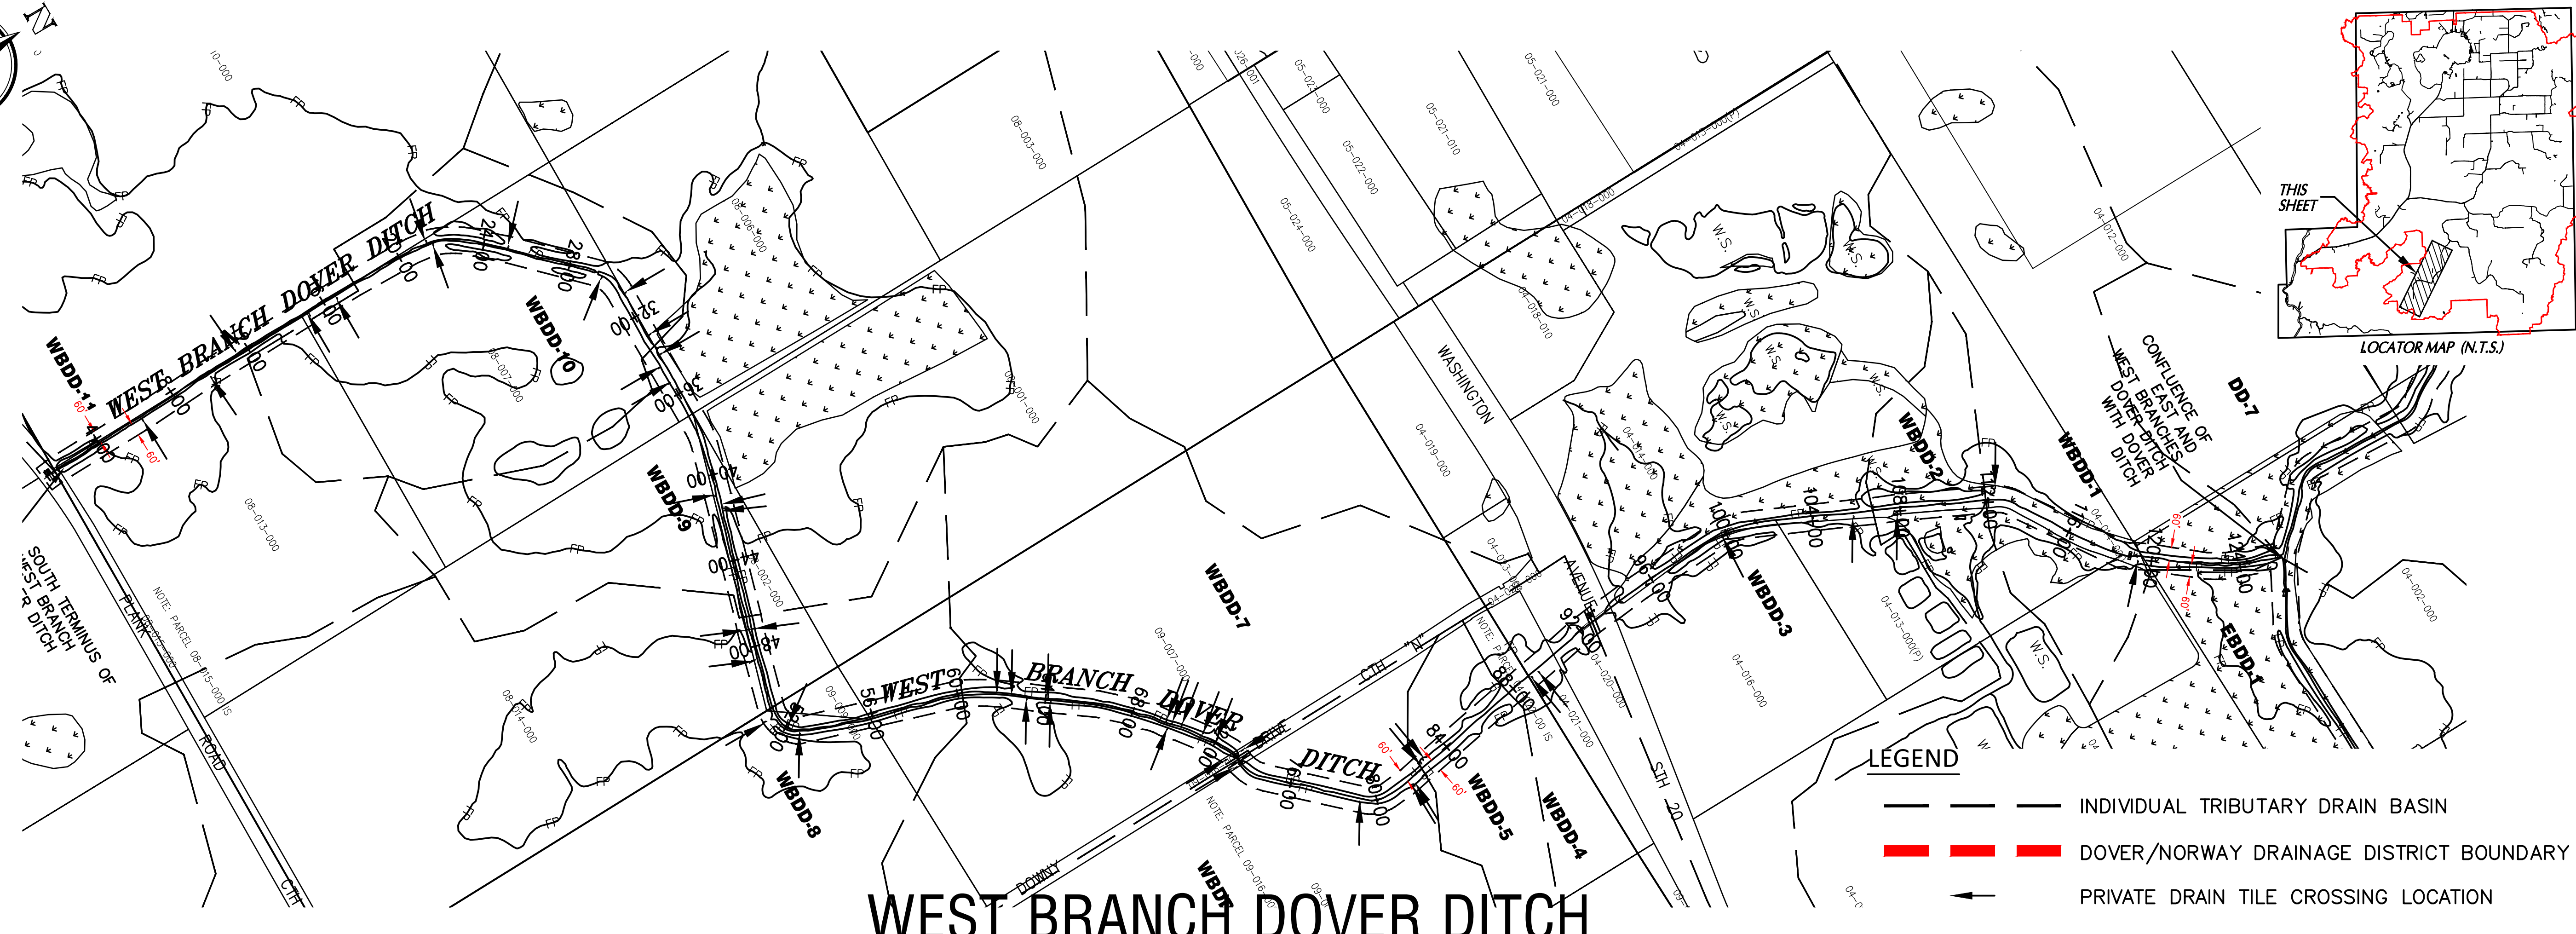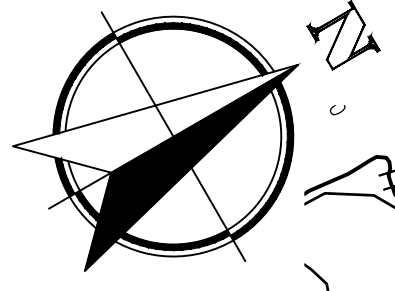


WEST BRANCH DOVER DITCH

TILE/CULVERT LOCATIONS
 SCALES:
 1" = 400' HOR
 1" = 4' VER

- LEGEND**
- INDIVIDUAL TRIBUTARY DRAIN BASIN
 - DOVER/NORWAY DRAINAGE DISTRICT BOUNDARY
 - PRIVATE DRAIN TILE CROSSING LOCATION

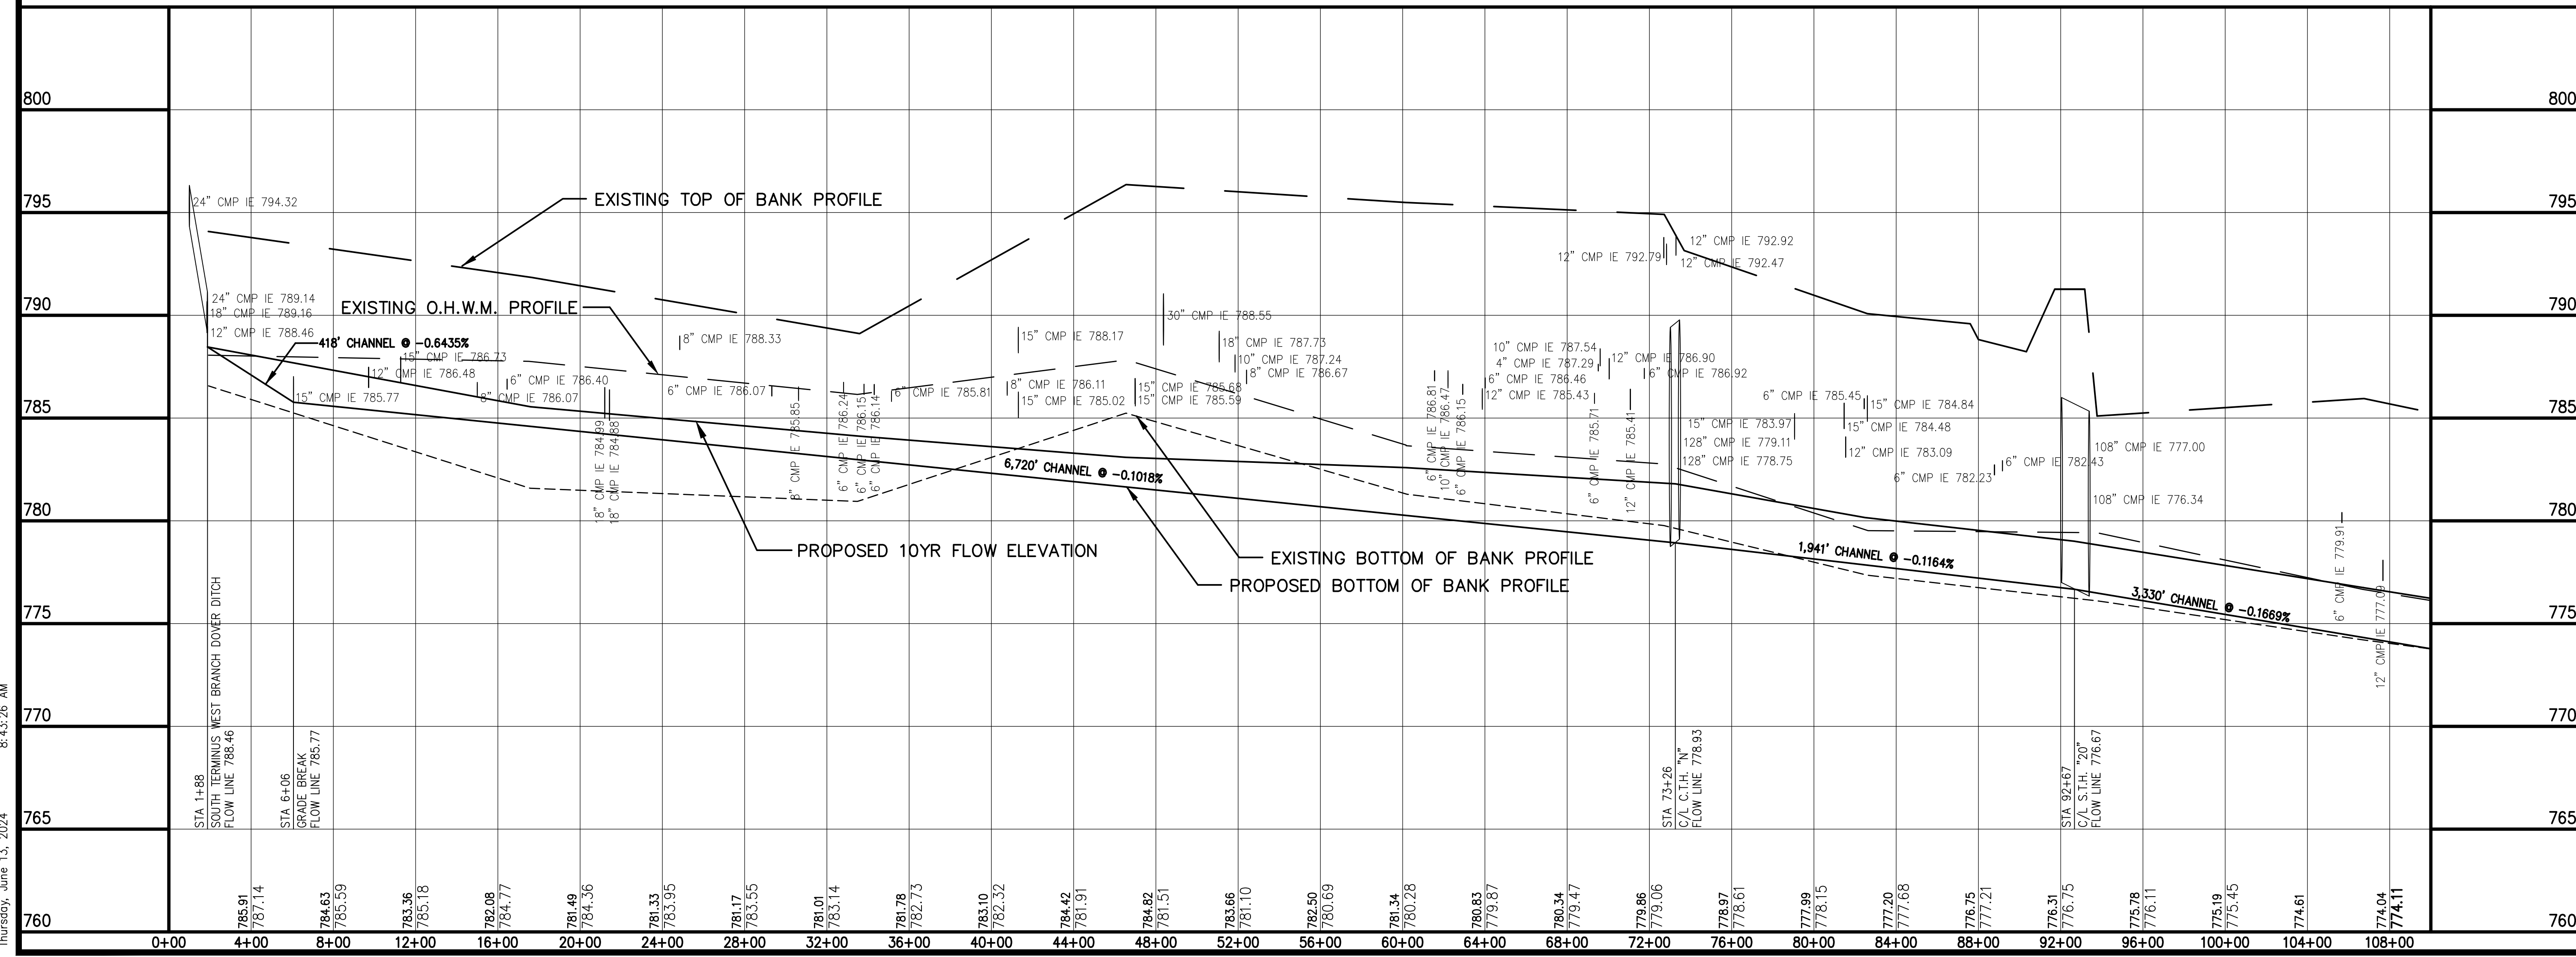

Thursday, June 13, 2024 8:43:26 AM



Nielsen Madsen & Barber S.C.
 Civil Engineers and Land Surveyors
 1339 Washington Ave. Racine, WI. 53403
 Tele: (262)634-5588 Fax: (262)634-5024
 Website www.nmbssc.net

DOVER / NORWAY DRAINAGE DISTRICT MAPPING WEST BRANCH DOVER DITCH PLAN AND PROFILE
 RACINE WISCONSIN

NO.	REVISION	BY	DATE
1	REVISE ARROW DIRECTION TO REFLECT FLOW	SCB	11-18-10
2	UPDATE DISTRICT CORRIDORS	SCB	06-13-24

PROJ. MGR:	MRM
DRAFTED:	SCB
DATE:	6-15-2010
CHECKED:	JCB
DATE:	6-15-2010

2010.0022.01

21 OF **83**





Nielsen Madsen & Barber S.C.
 Civil Engineers and Land Surveyors
 1339 Washington Ave. Racine, WI. 53403
 Tele: (262)634-5588 Fax: (262)634-5024
 Website www.nmbcsc.net

DOVER / NORWAY DRAINAGE DISTRICT MAPPING WEST BRANCH DOVER DITCH PLAN AND PROFILE
 RACINE WISCONSIN



NO.	REVISION	BY	DATE
1	REVISE ARROW DIRECTION TO REFLECT FLOW	SCB	11-18-10
2	UPDATE DISTRICT CORRIDORS	SCB	06-13-24

PROJ. MGR: MRM
 DRAFTED: SCB
 DATE: 6-15-2010
 CHECKED: JCB
 DATE: 6-15-2010

2010.0022.01
 SHEET
 22 OF 83

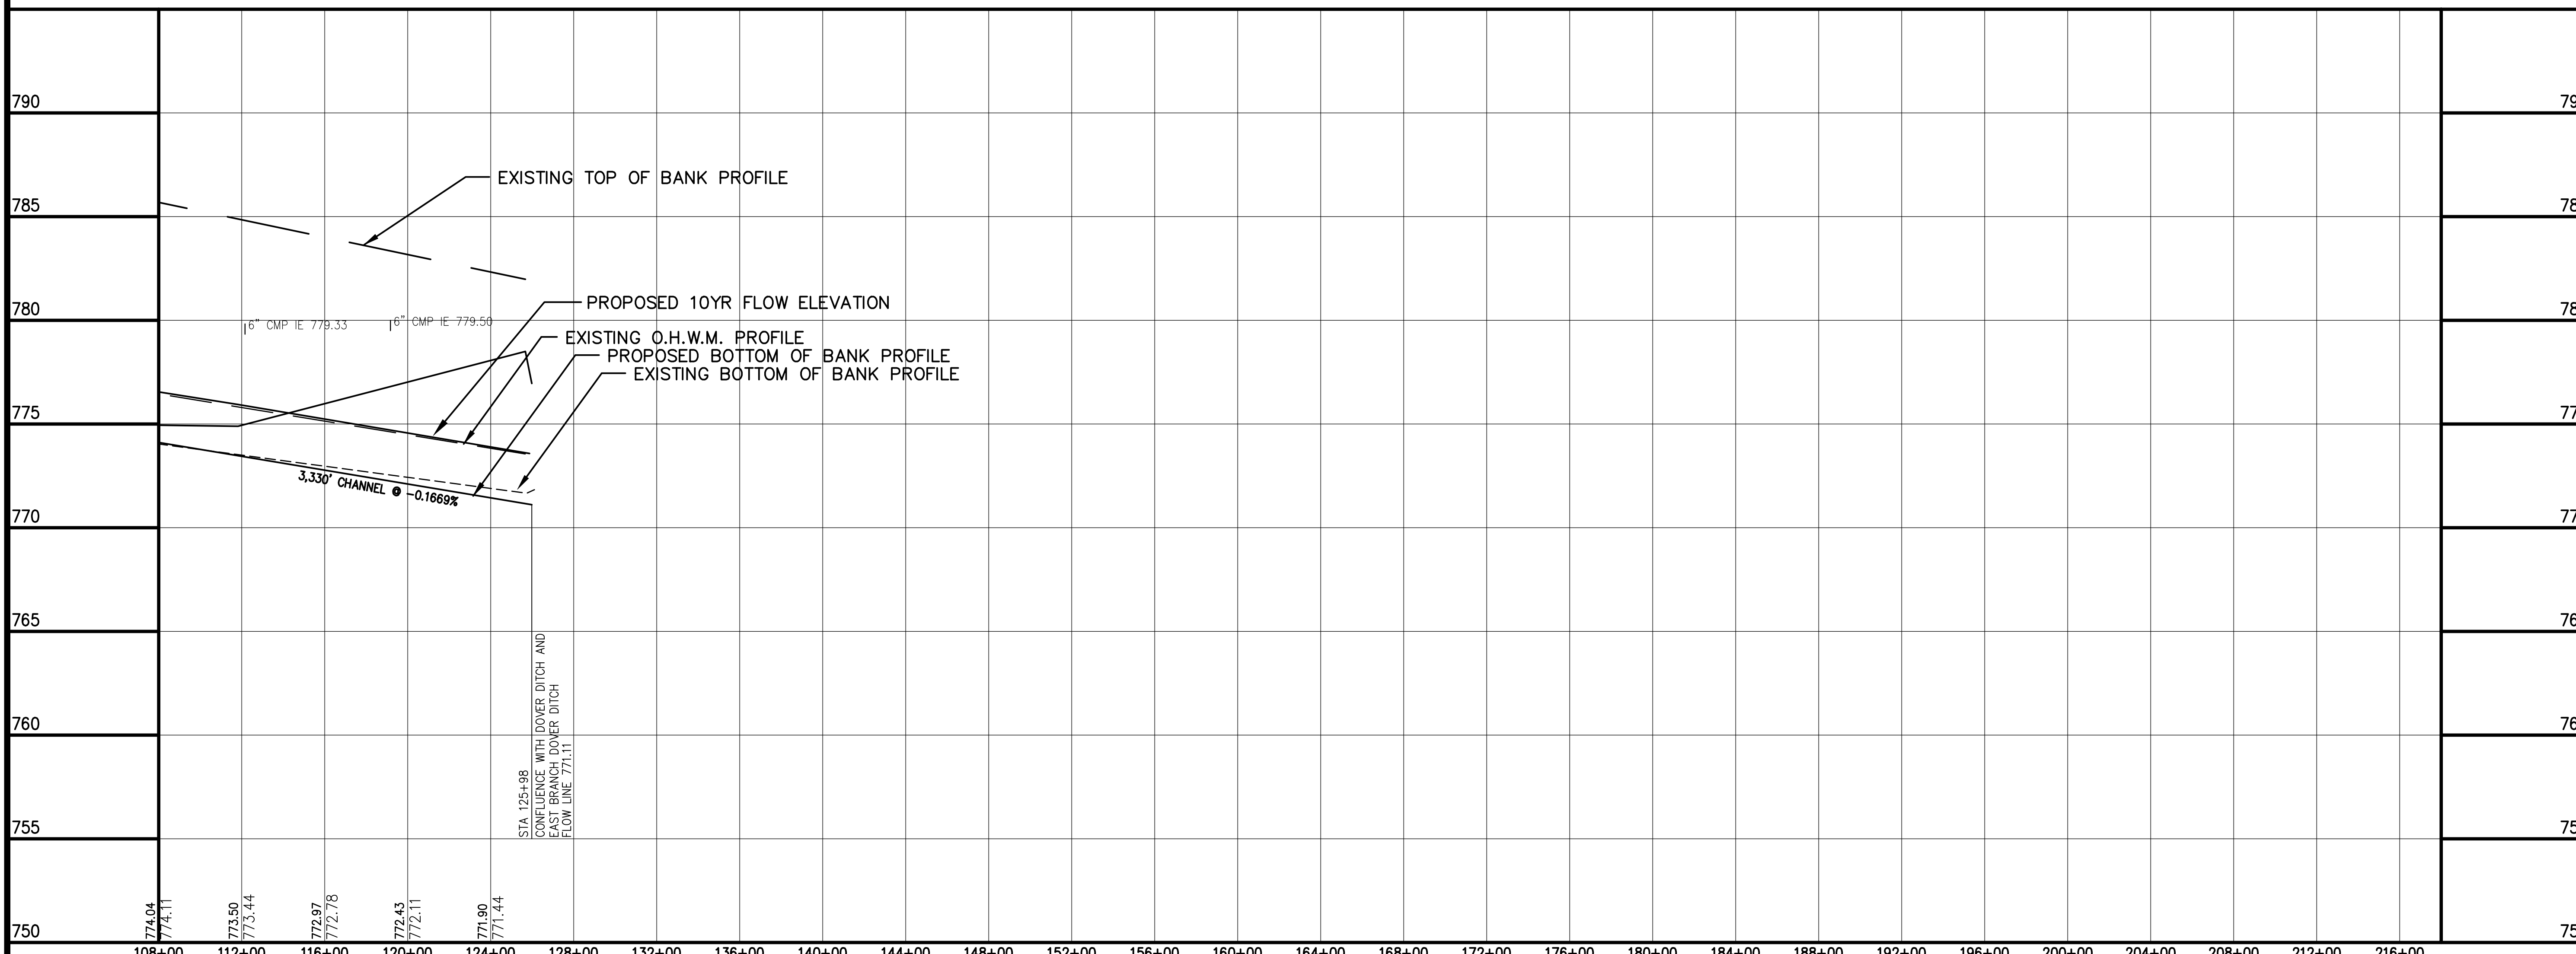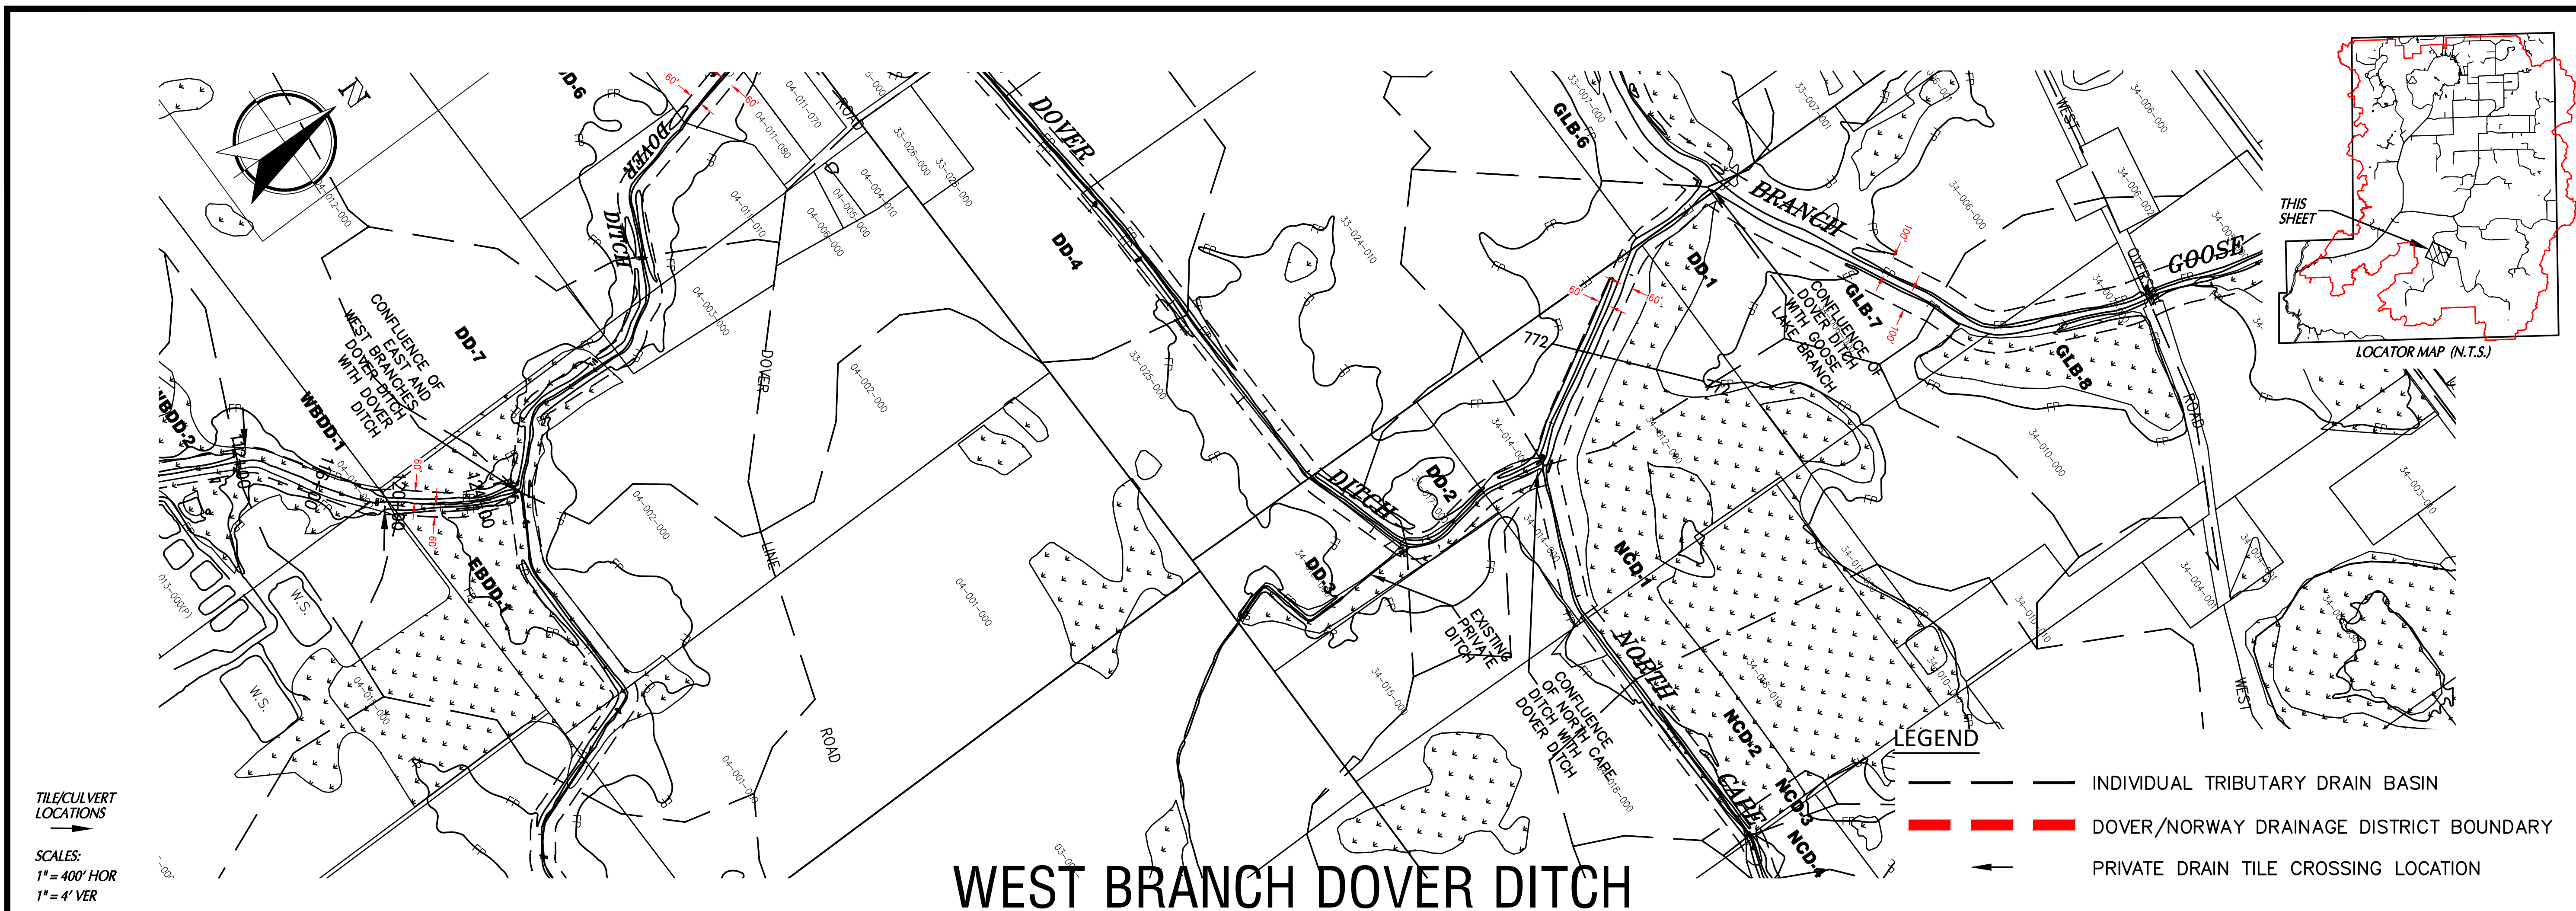


Thursday, June 13, 2024 8:44:12 AM

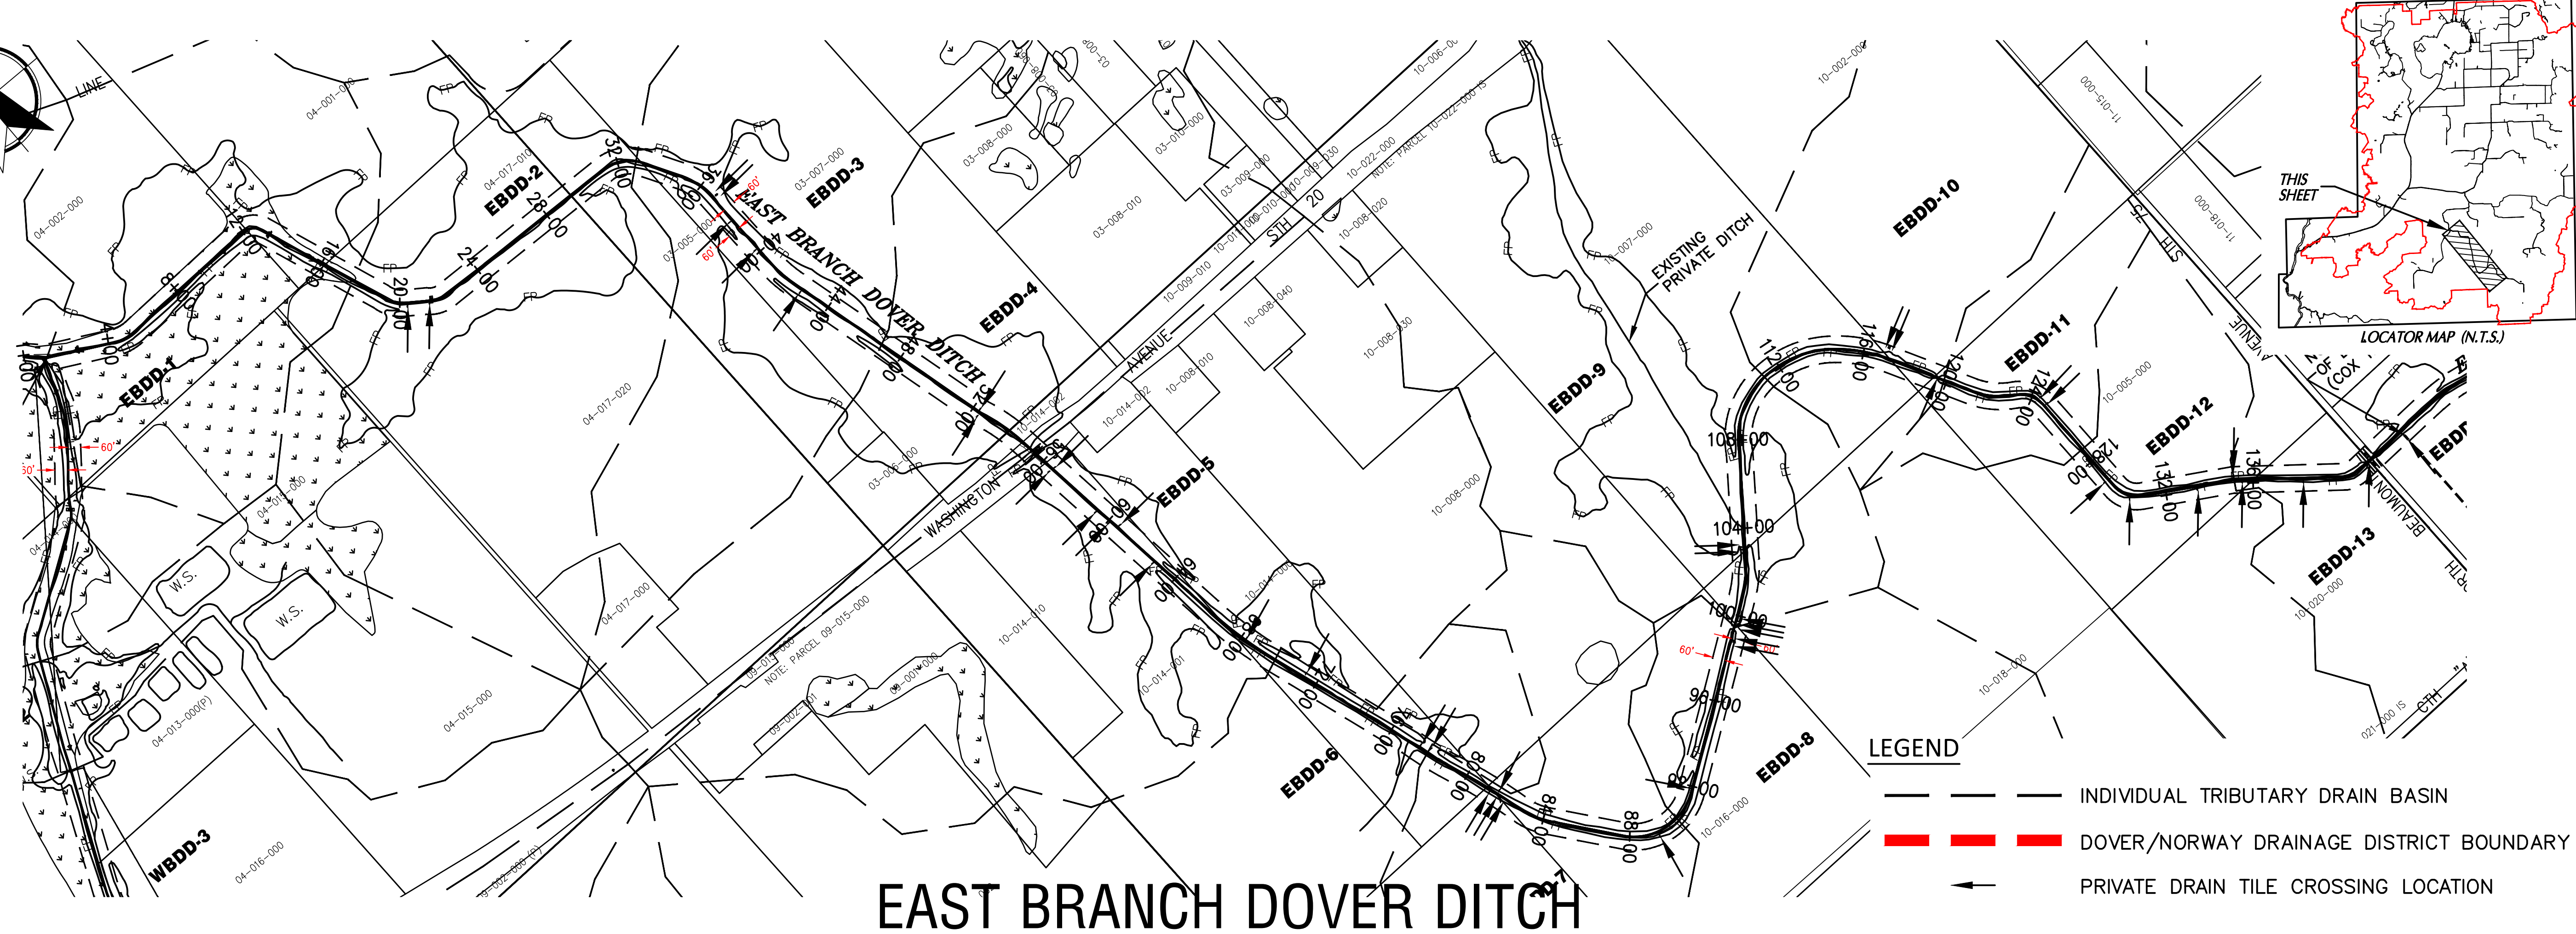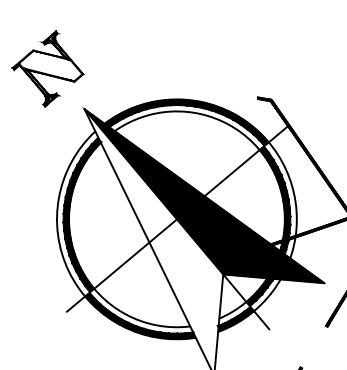


TILE/CULVERT LOCATIONS
 SCALES:
 1" = 400' HOR
 1" = 4' VER

EAST BRANCH DOVER DITCH

- LEGEND**
- INDIVIDUAL TRIBUTARY DRAIN BASIN
 - DOVER/NORWAY DRAINAGE DISTRICT BOUNDARY
 - ← PRIVATE DRAIN TILE CROSSING LOCATION

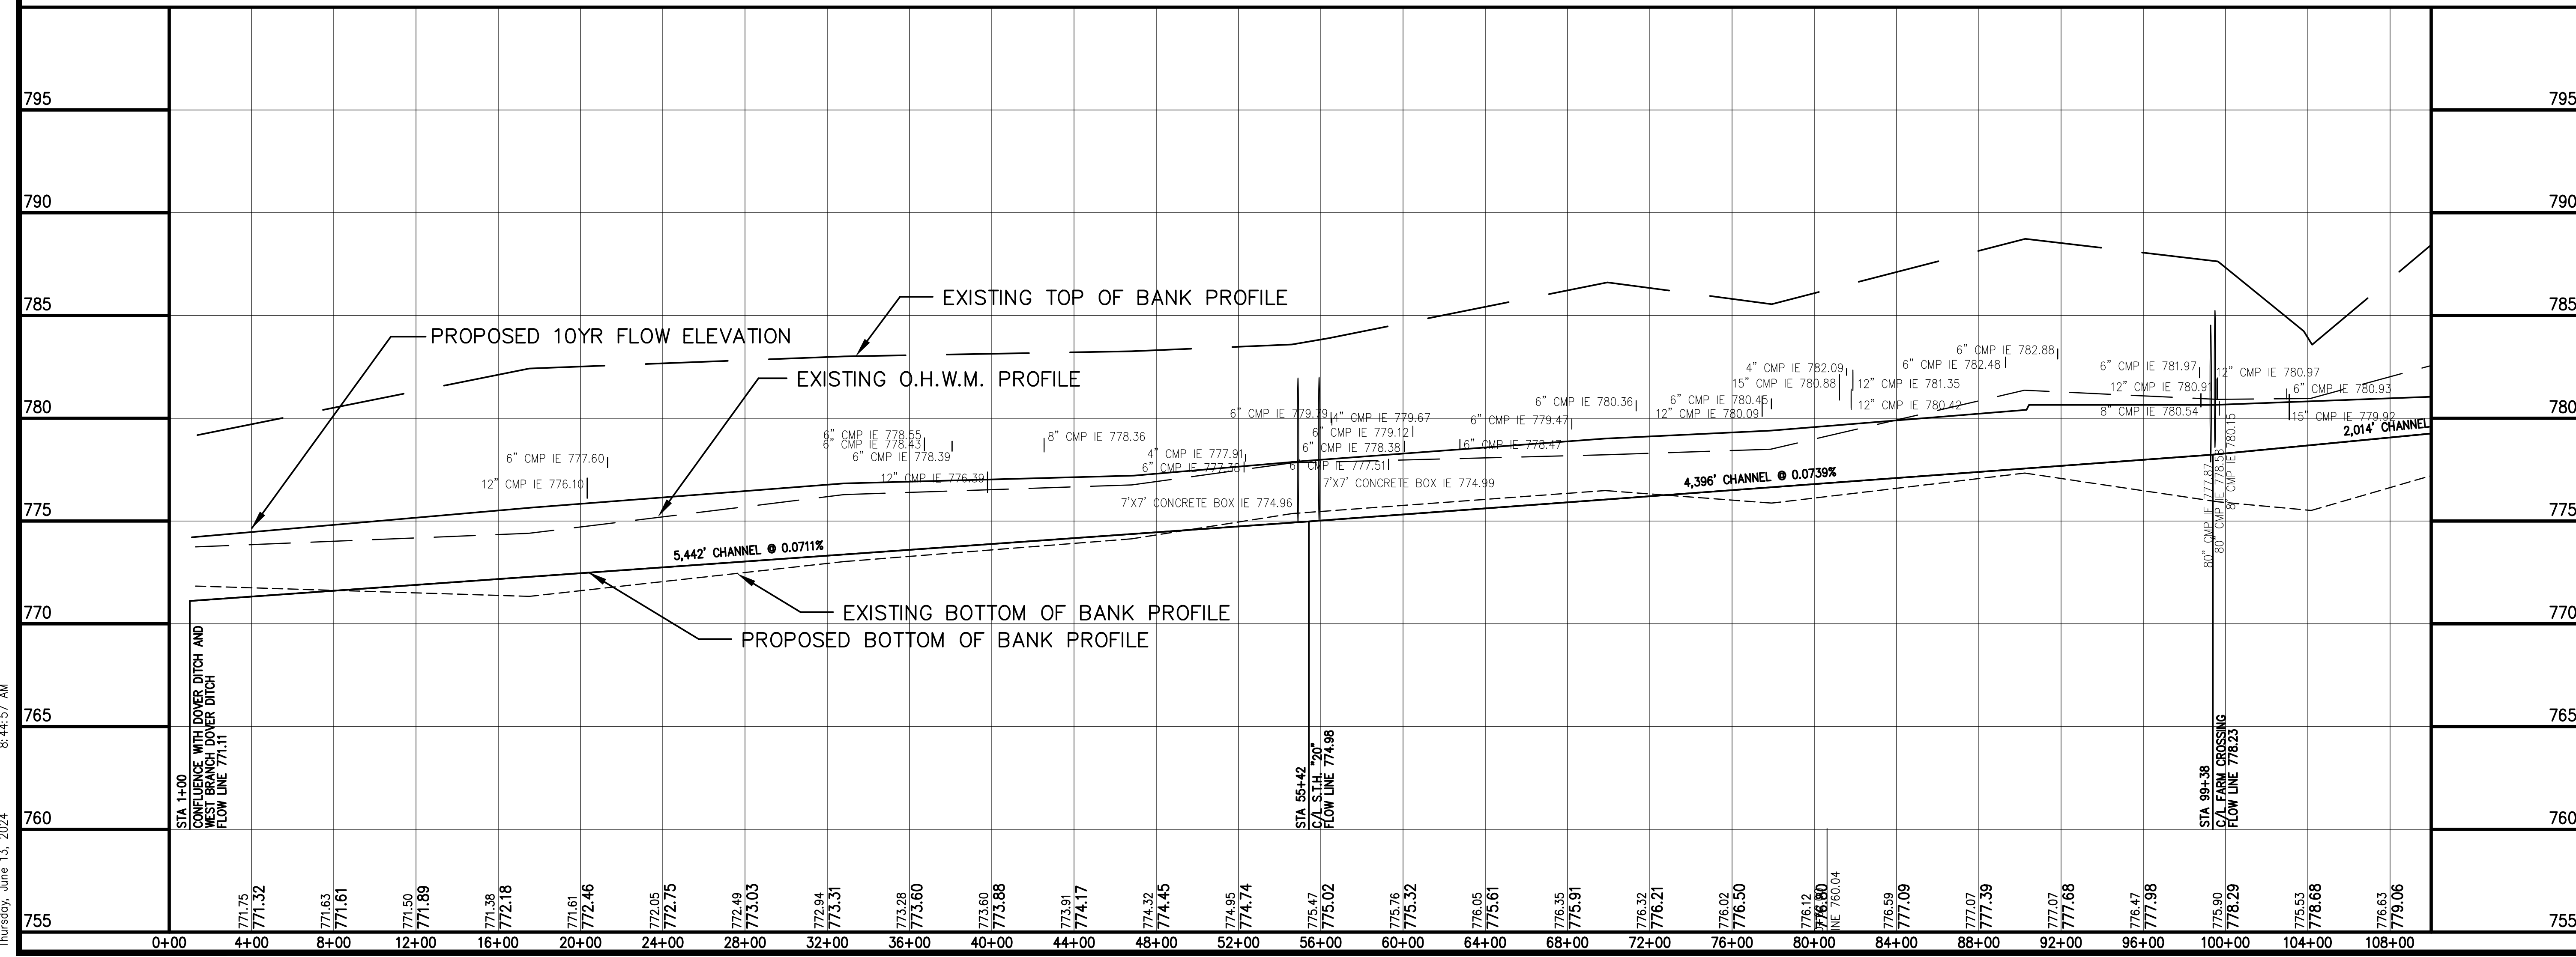

Thursday, June 13, 2024 8:44:57 AM




Nielsen Madsen & Barber S.C.
 Civil Engineers and Land Surveyors
 1339 Washington Ave. Racine, WI. 53403
 Tele: (262)634-5588 Fax: (262)634-5024
 Website www.nmbssc.net



DOVER / NORWAY DRAINAGE DISTRICT MAPPING EAST BRANCH DOVER DITCH PLAN AND PROFILE
 RACINE WISCONSIN

NO.	REVISION	DATE
1	REVISE ARROW DIRECTION TO REFLECT FLOW	SCB 11-18-10
2	DRAINAGE DISTRICT BOUNDARY UPDATED	SCB 5-31-11
3	UPDATE DISTRICT CORRIDORS	SCB 06-13-24


PROJ. MGR: JMR
 DRAFTED: SCB
 DATE: 6-15-2010
 CHECKED: JCB
 DATE: 6-15-2010

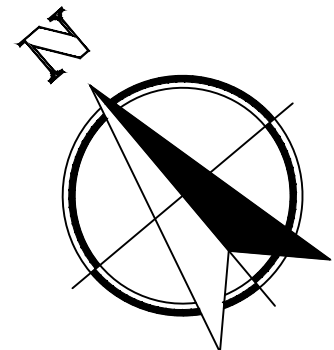

TILE/CULVERT LOCATIONS
 SCALES:
 1" = 400' HOR
 1" = 4' VER

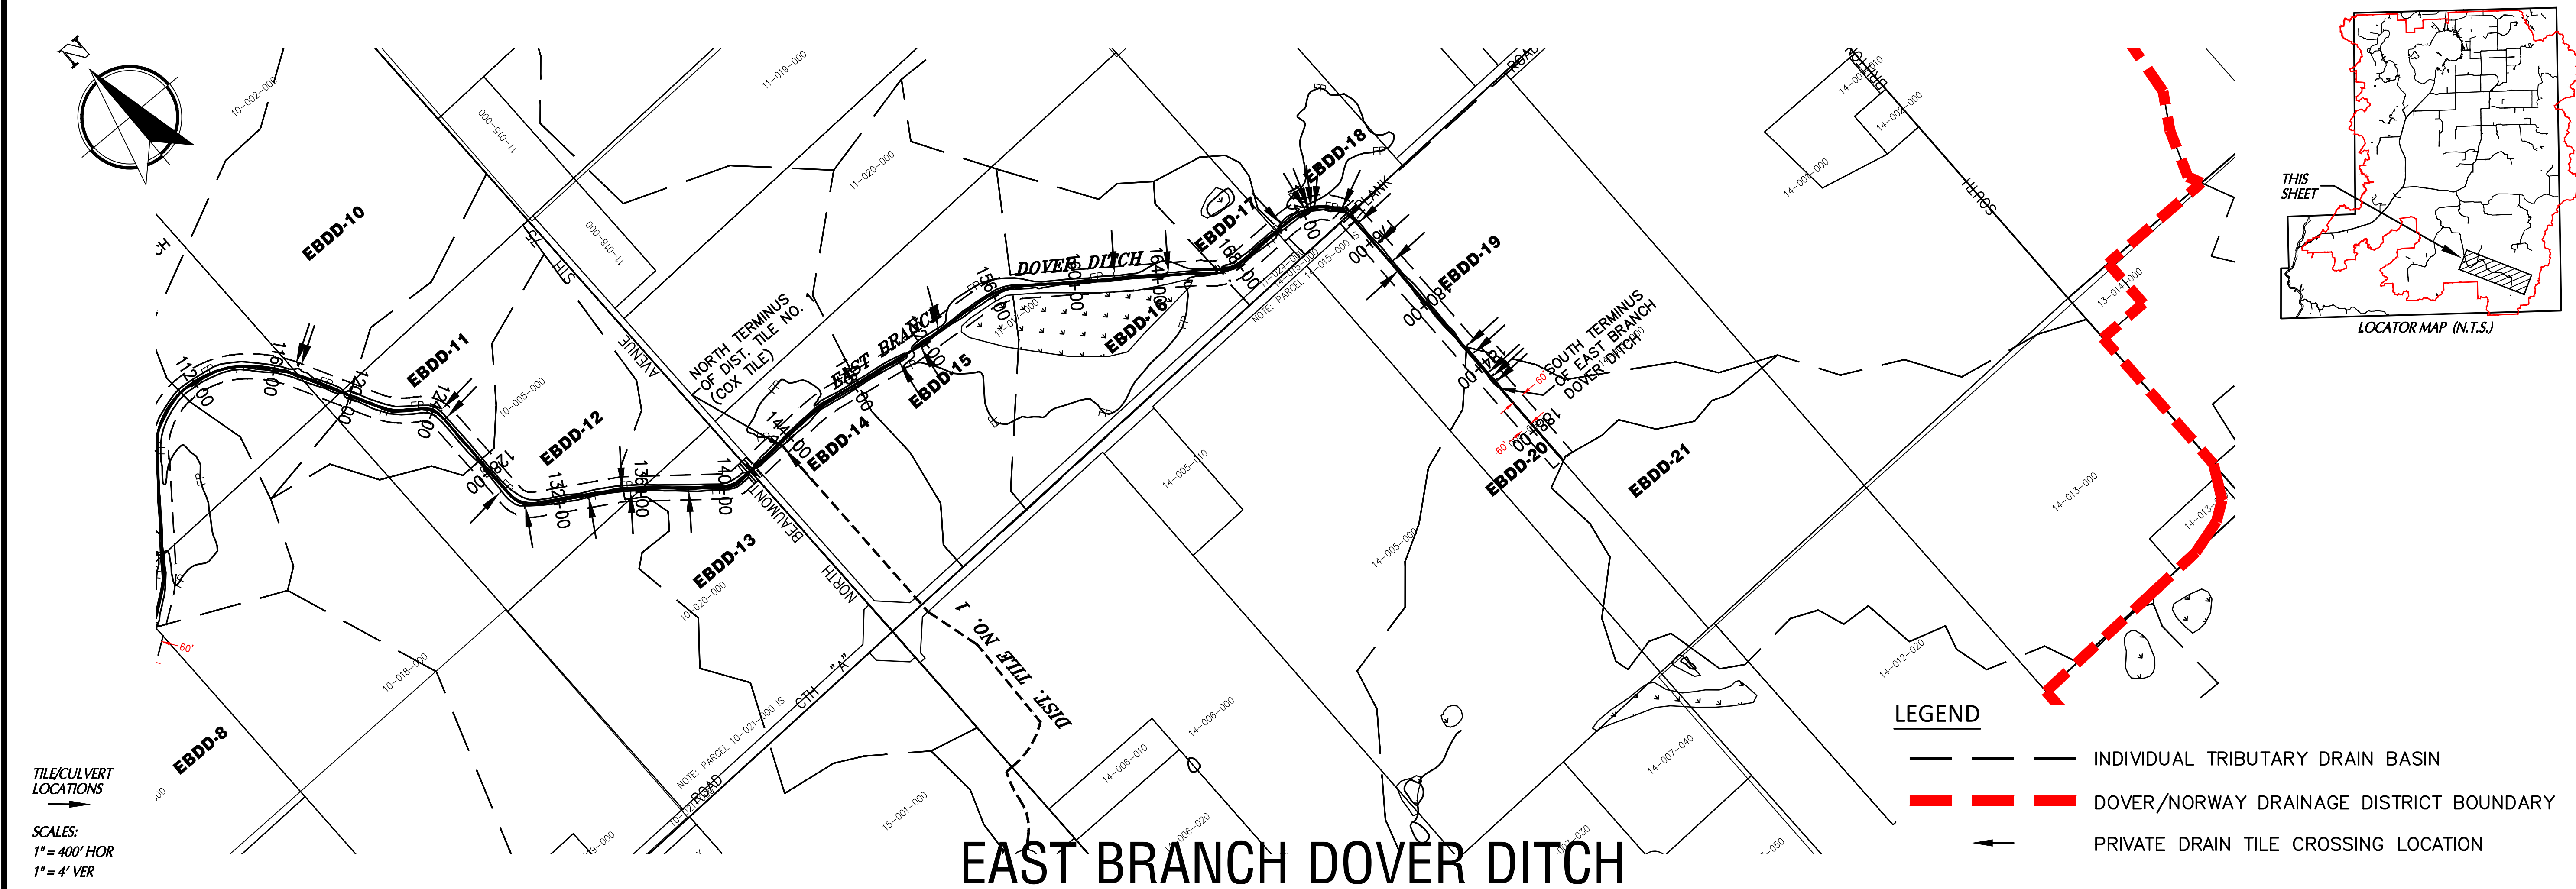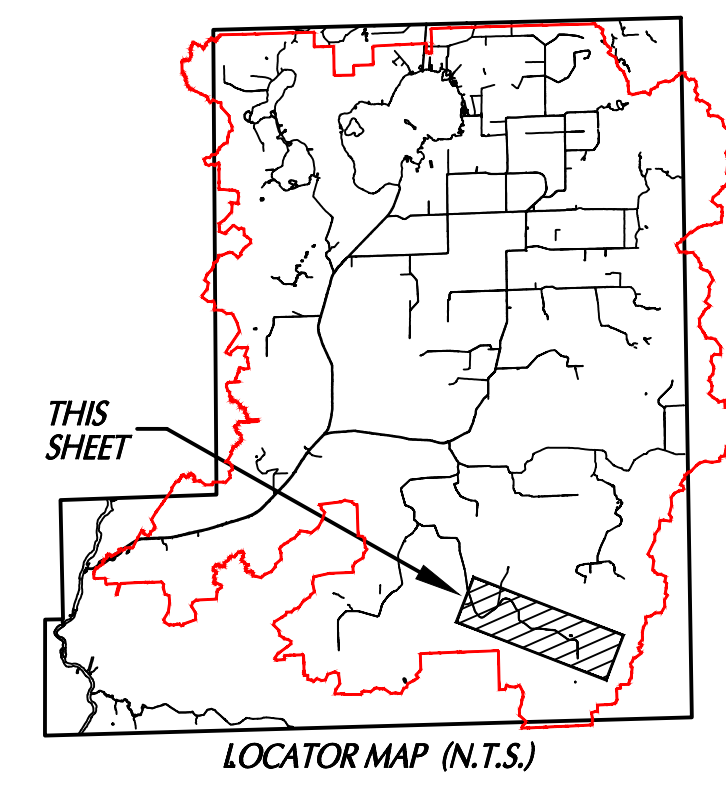

EAST BRANCH DOVER DITCH

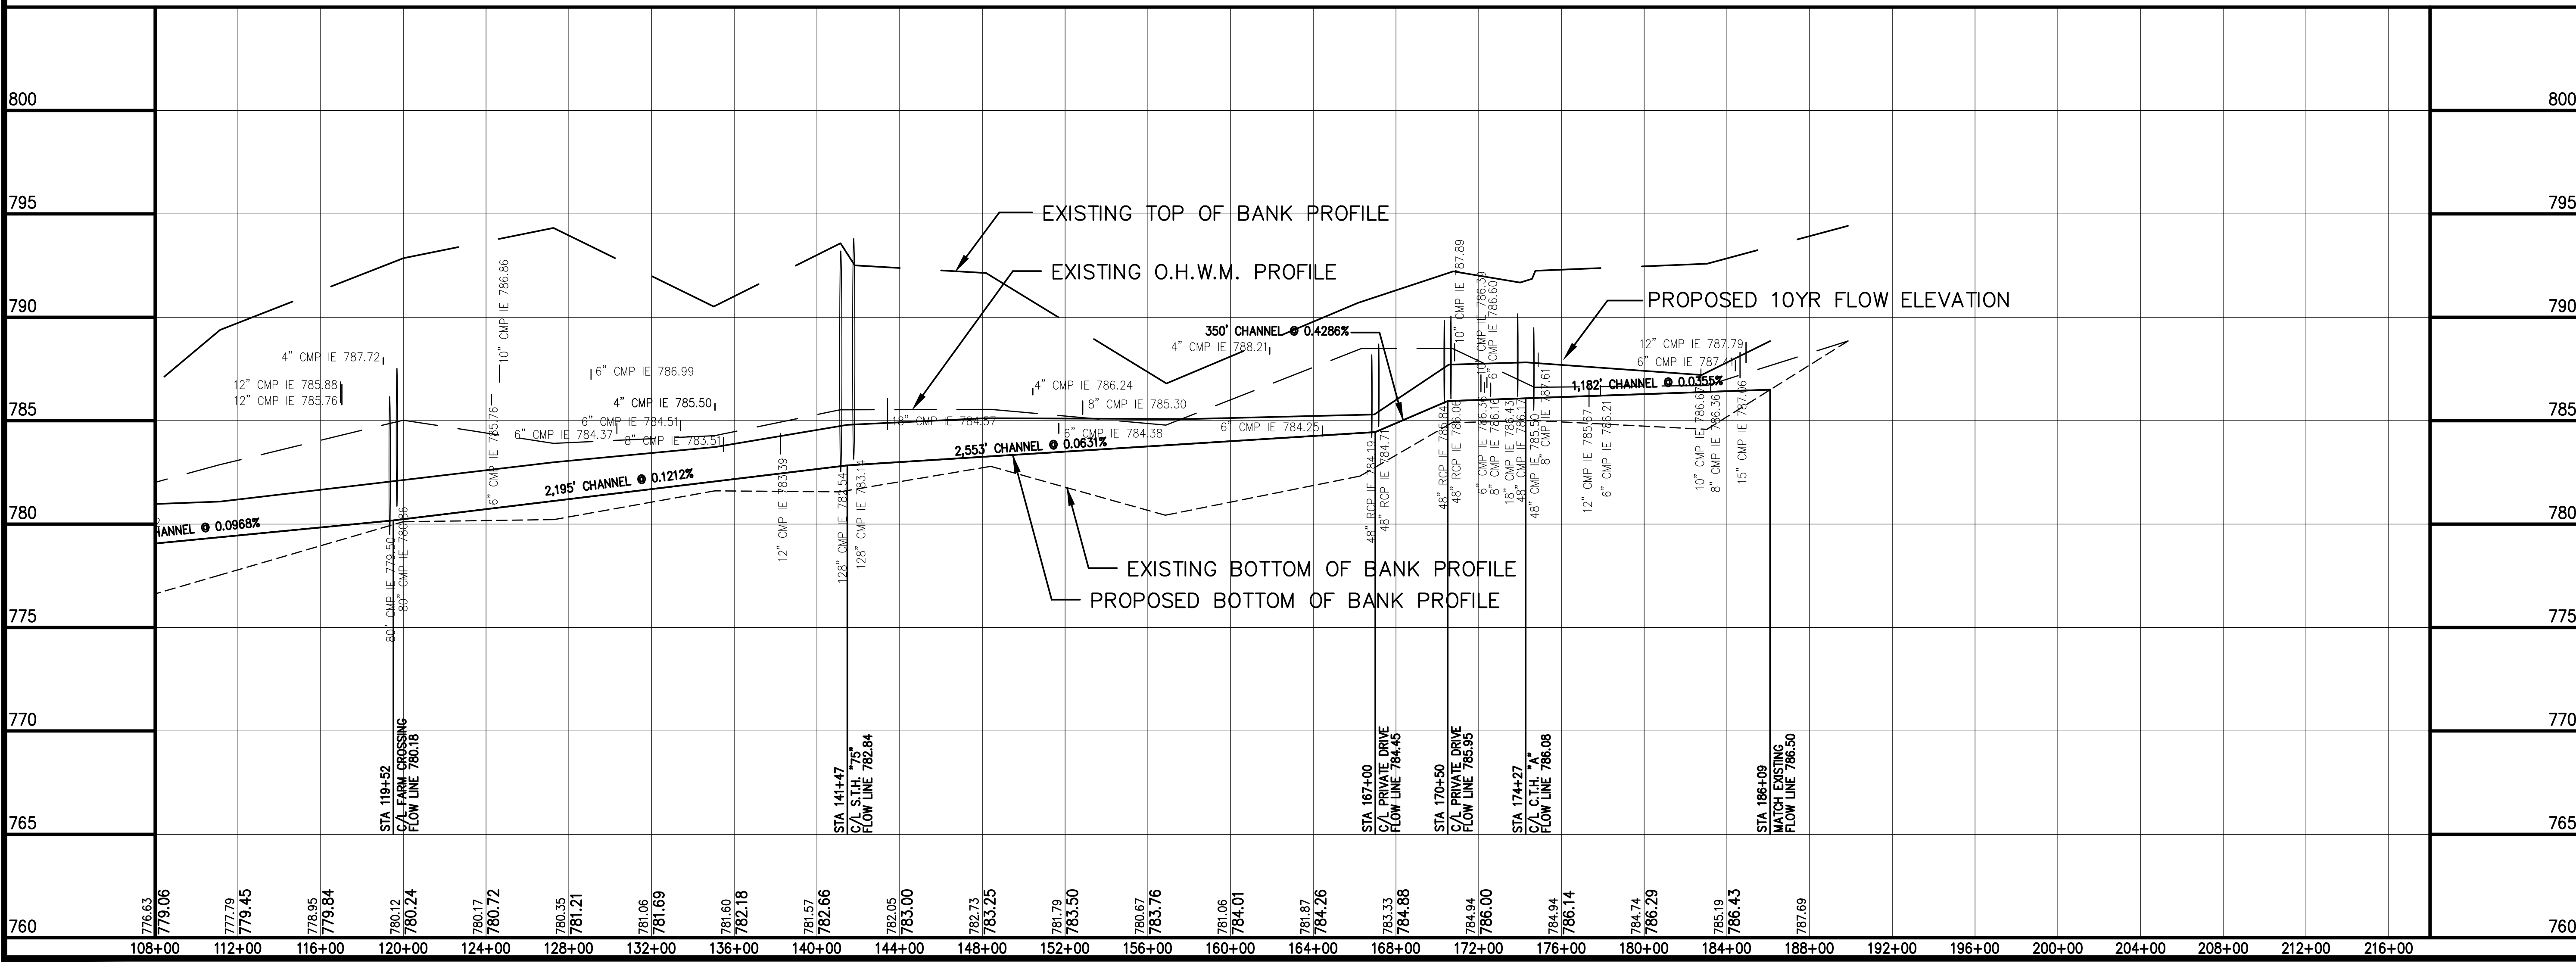

LEGEND

- — — — — INDIVIDUAL TRIBUTARY DRAIN BASIN
- - - - - DOVER/NORWAY DRAINAGE DISTRICT BOUNDARY
- ← PRIVATE DRAIN TILE CROSSING LOCATION


DOVER / NORWAY DRAINAGE DISTRICT MAPPING EAST BRANCH DOVER DITCH PLAN AND PROFILE

RACINE WISCONSIN



NO.	REVISION	BY	DATE
1	REVISE ARROW DIRECTION TO REFLECT FLOW	SCB	11-18-10
2	SHOW LOCATION OF DISTRICT TILE NO. 1	ICB	12-1-10
3	UPDATE DISTRICT CORRIDORS	SCB	06-13-24

PROJ. MGR: MRM
 DRAFTED: SCB
 DATE: 6-15-2010
 CHECKED: ICB
 DATE: 6-15-2010


2010.0022.01
 SHEET
 24 OF 83



Nielsen Madsen & Barber S.C.
 Civil Engineers and Land Surveyors
 1339 Washington Ave. Racine, WI. 53403
 Tele: (262)634-5588 Fax: (262)634-5024
 Website www.nmbssc.net

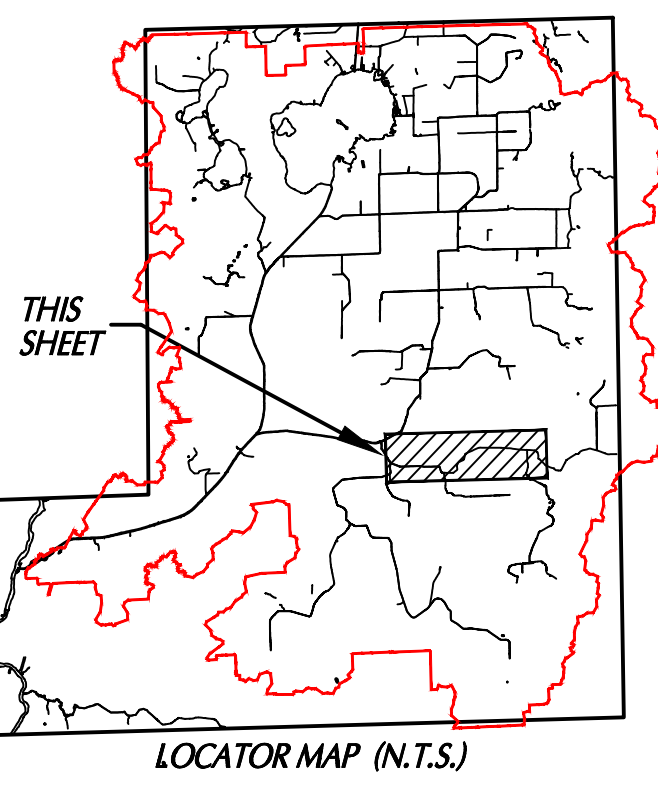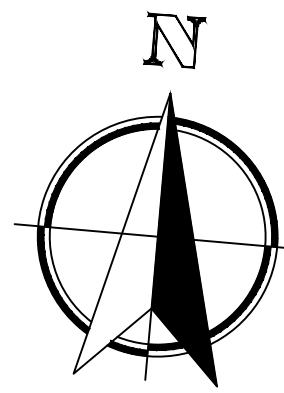


LOCATOR MAP (N.T.S.)

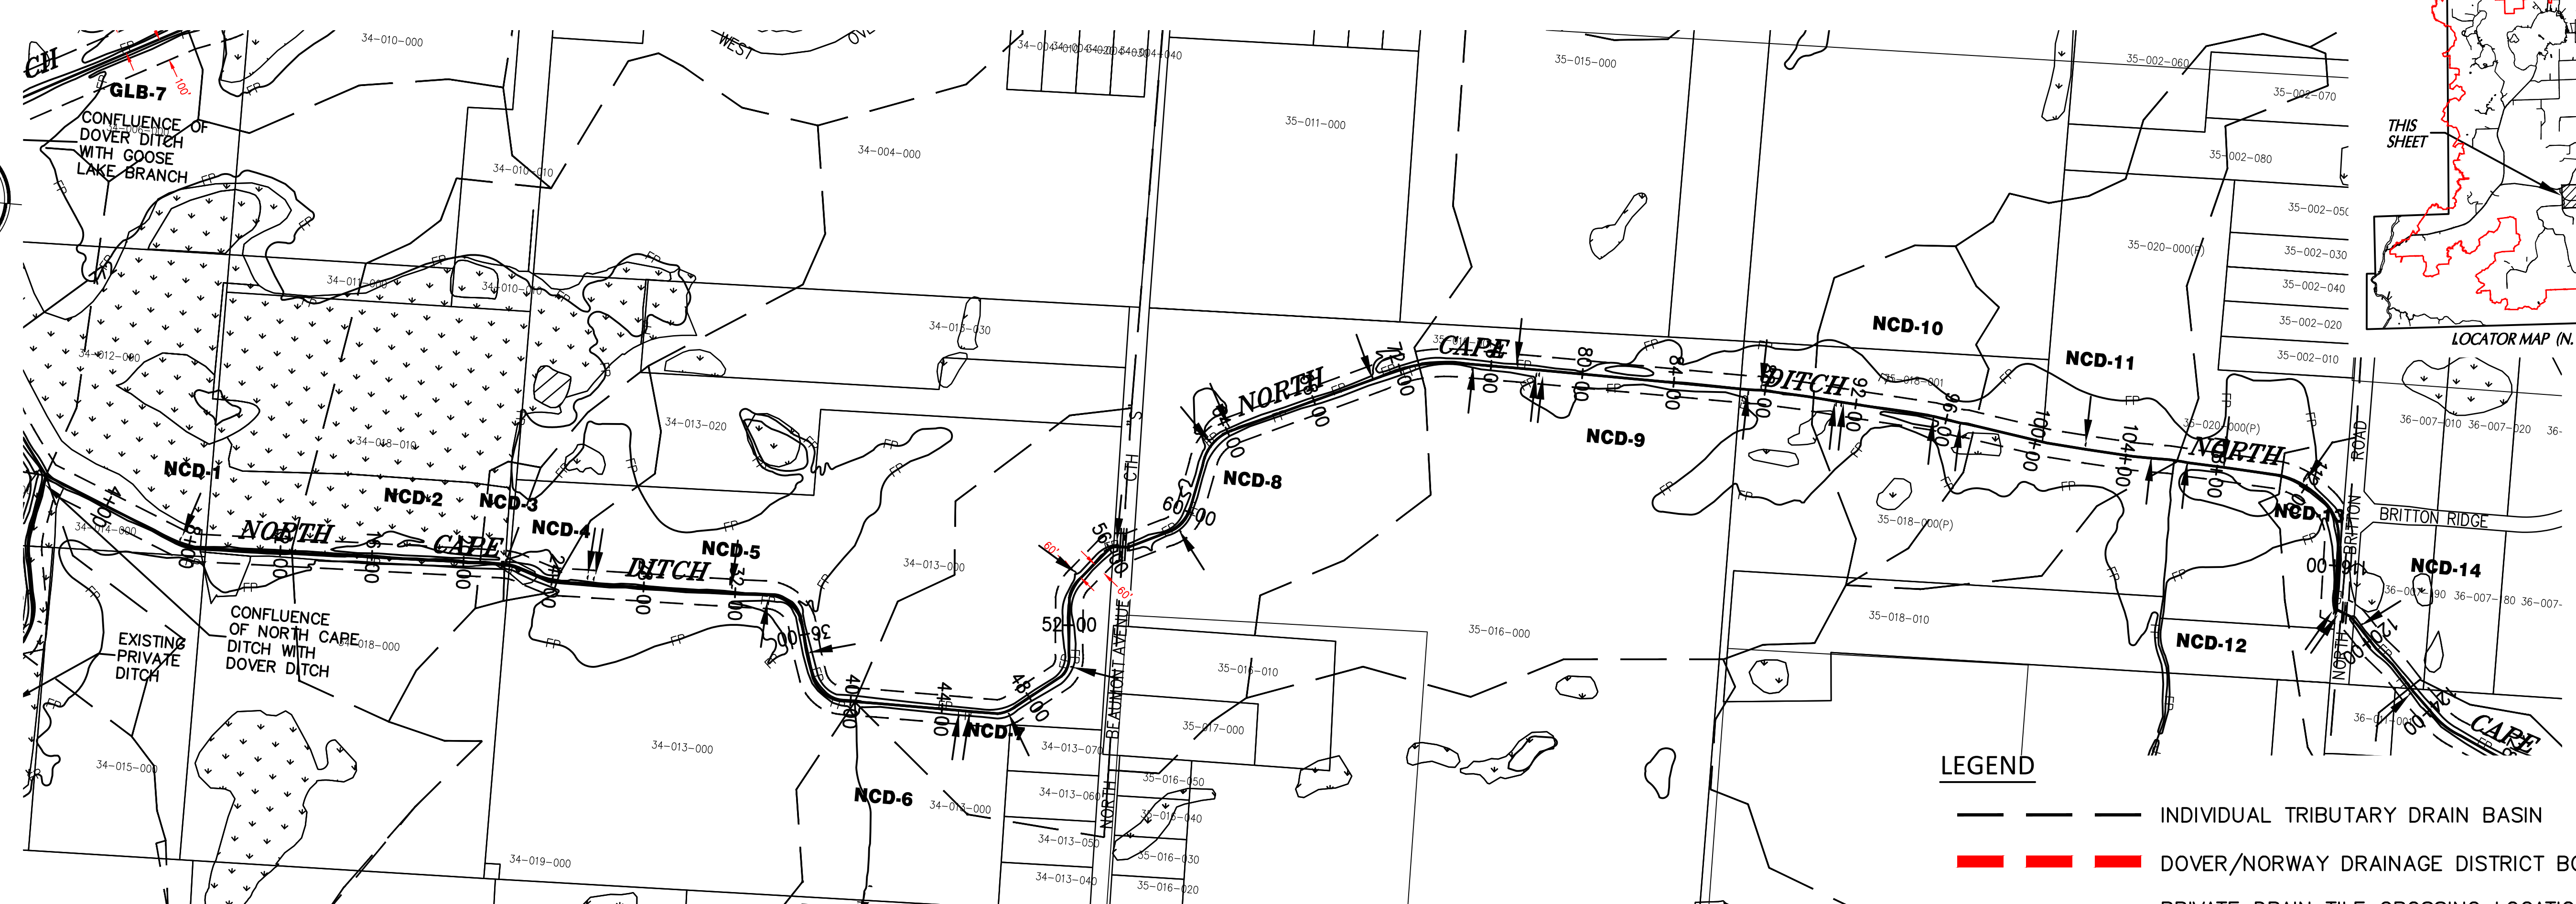

LEGEND

- INDIVIDUAL TRIBUTARY DRAIN BASIN
- DOVER/NORWAY DRAINAGE DISTRICT BOUNDARY
- PRIVATE DRAIN TILE CROSSING LOCATION

NORTH CAPE DITCH

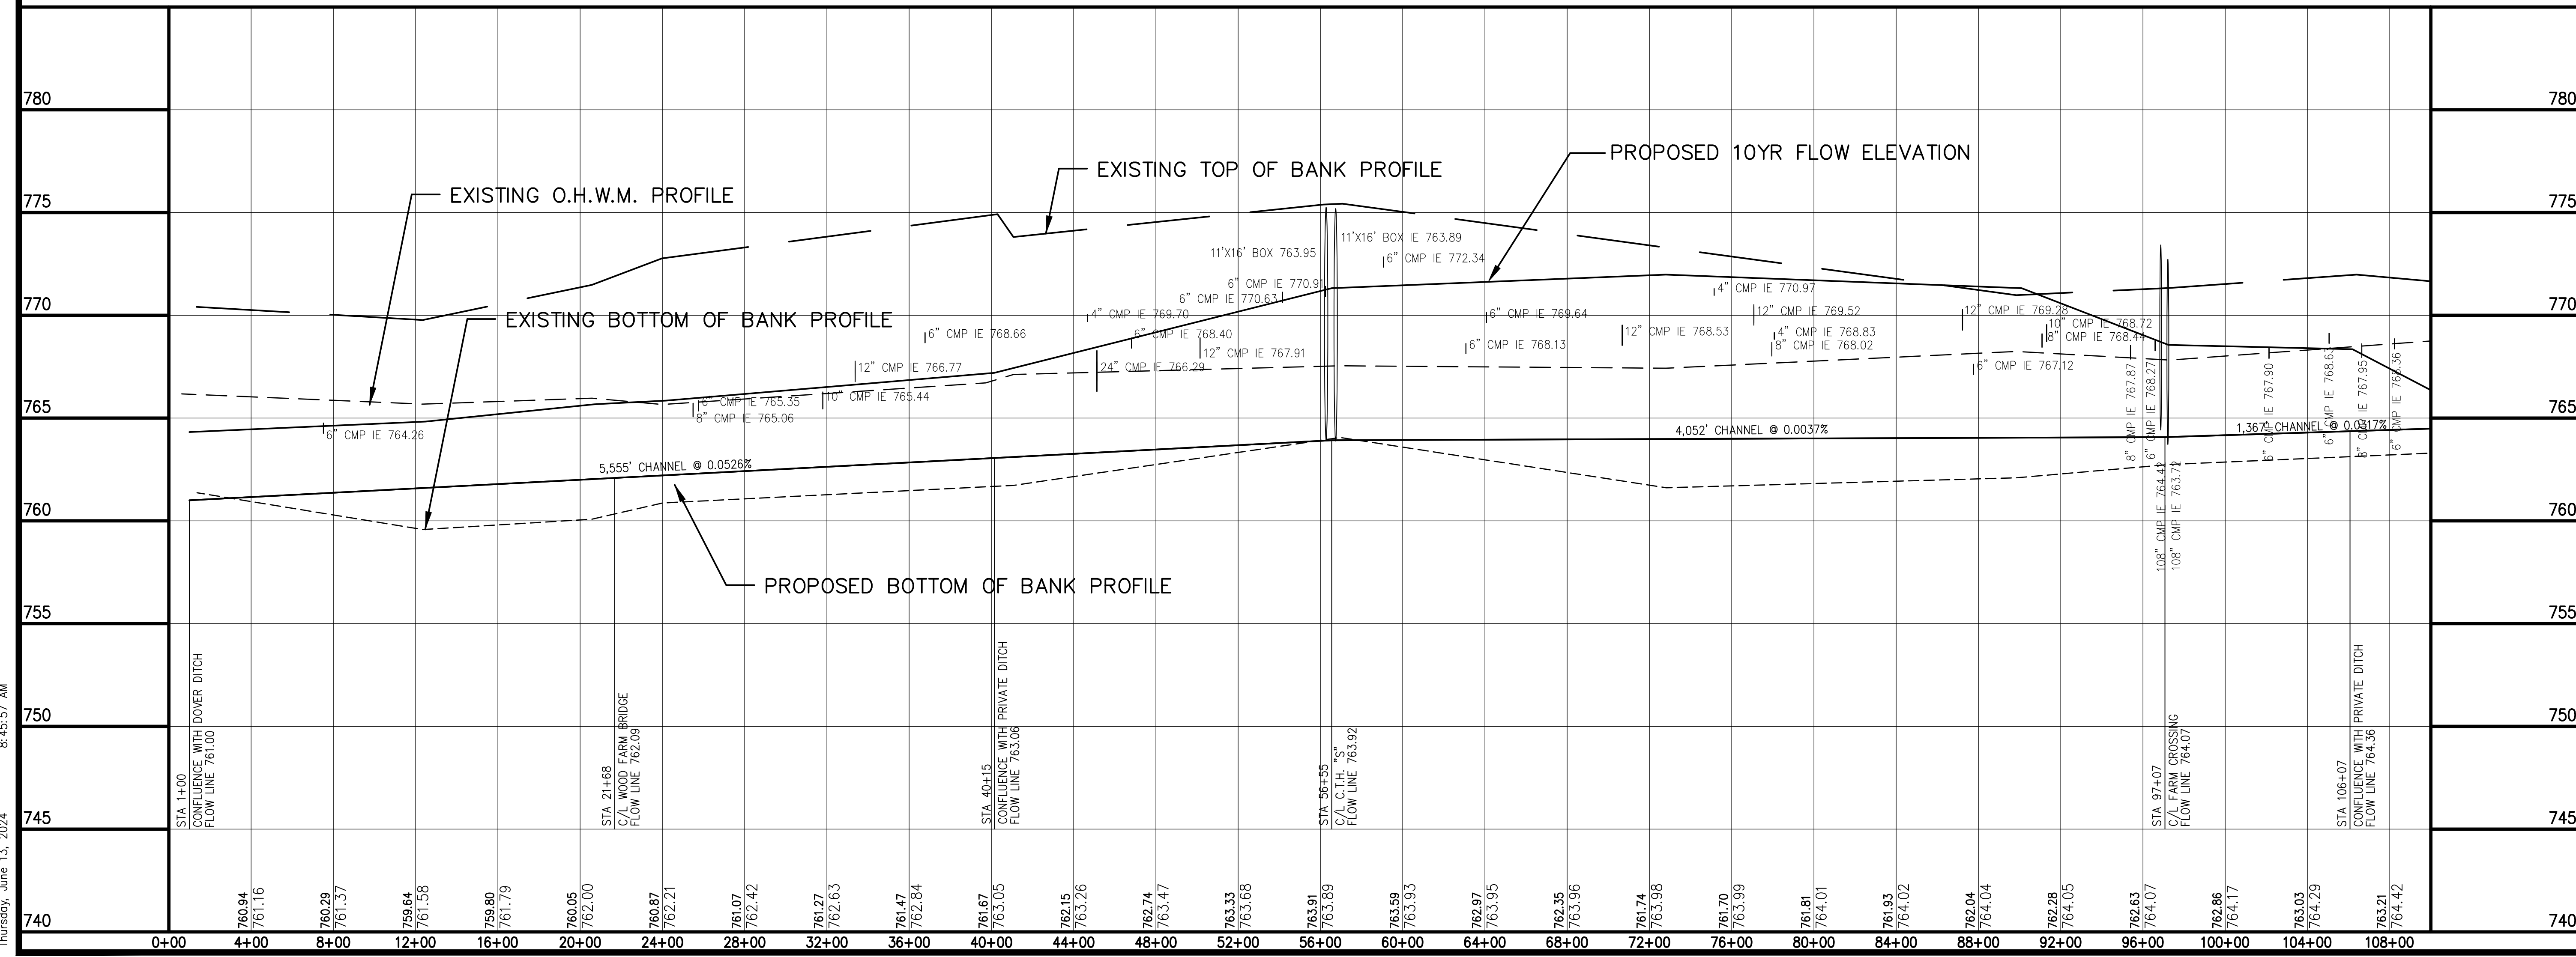


DOVER / NORWAY DRAINAGE DISTRICT MAPPING
NORTH CAPE DITCH PLAN AND PROFILE
 RACINE WISCONSIN

NO.	REVISION	BY	DATE
1	REVISE ARROW DIRECTION TO REFLECT FLOW	SCB	11-18-10
2	UPDATE DISTRICT CORRIDORS	SCB	06-13-24



PROJ. MGR: MRM
 DRAFTED: SCB
 DATE: 6-15-2010
 CHECKED: JCB
 DATE: 6-15-2010

2010.0022.01
 SHEET
25 OF **83**



Nielsen Madsen & Barber S.C.
 Civil Engineers and Land Surveyors
 1339 Washington Ave. Racine, WI. 53403
 Tele: (262)634-5588 Fax: (262)634-5024
 Website www.nmbssc.net

Thursday, June 13, 2024 8:45:57 AM

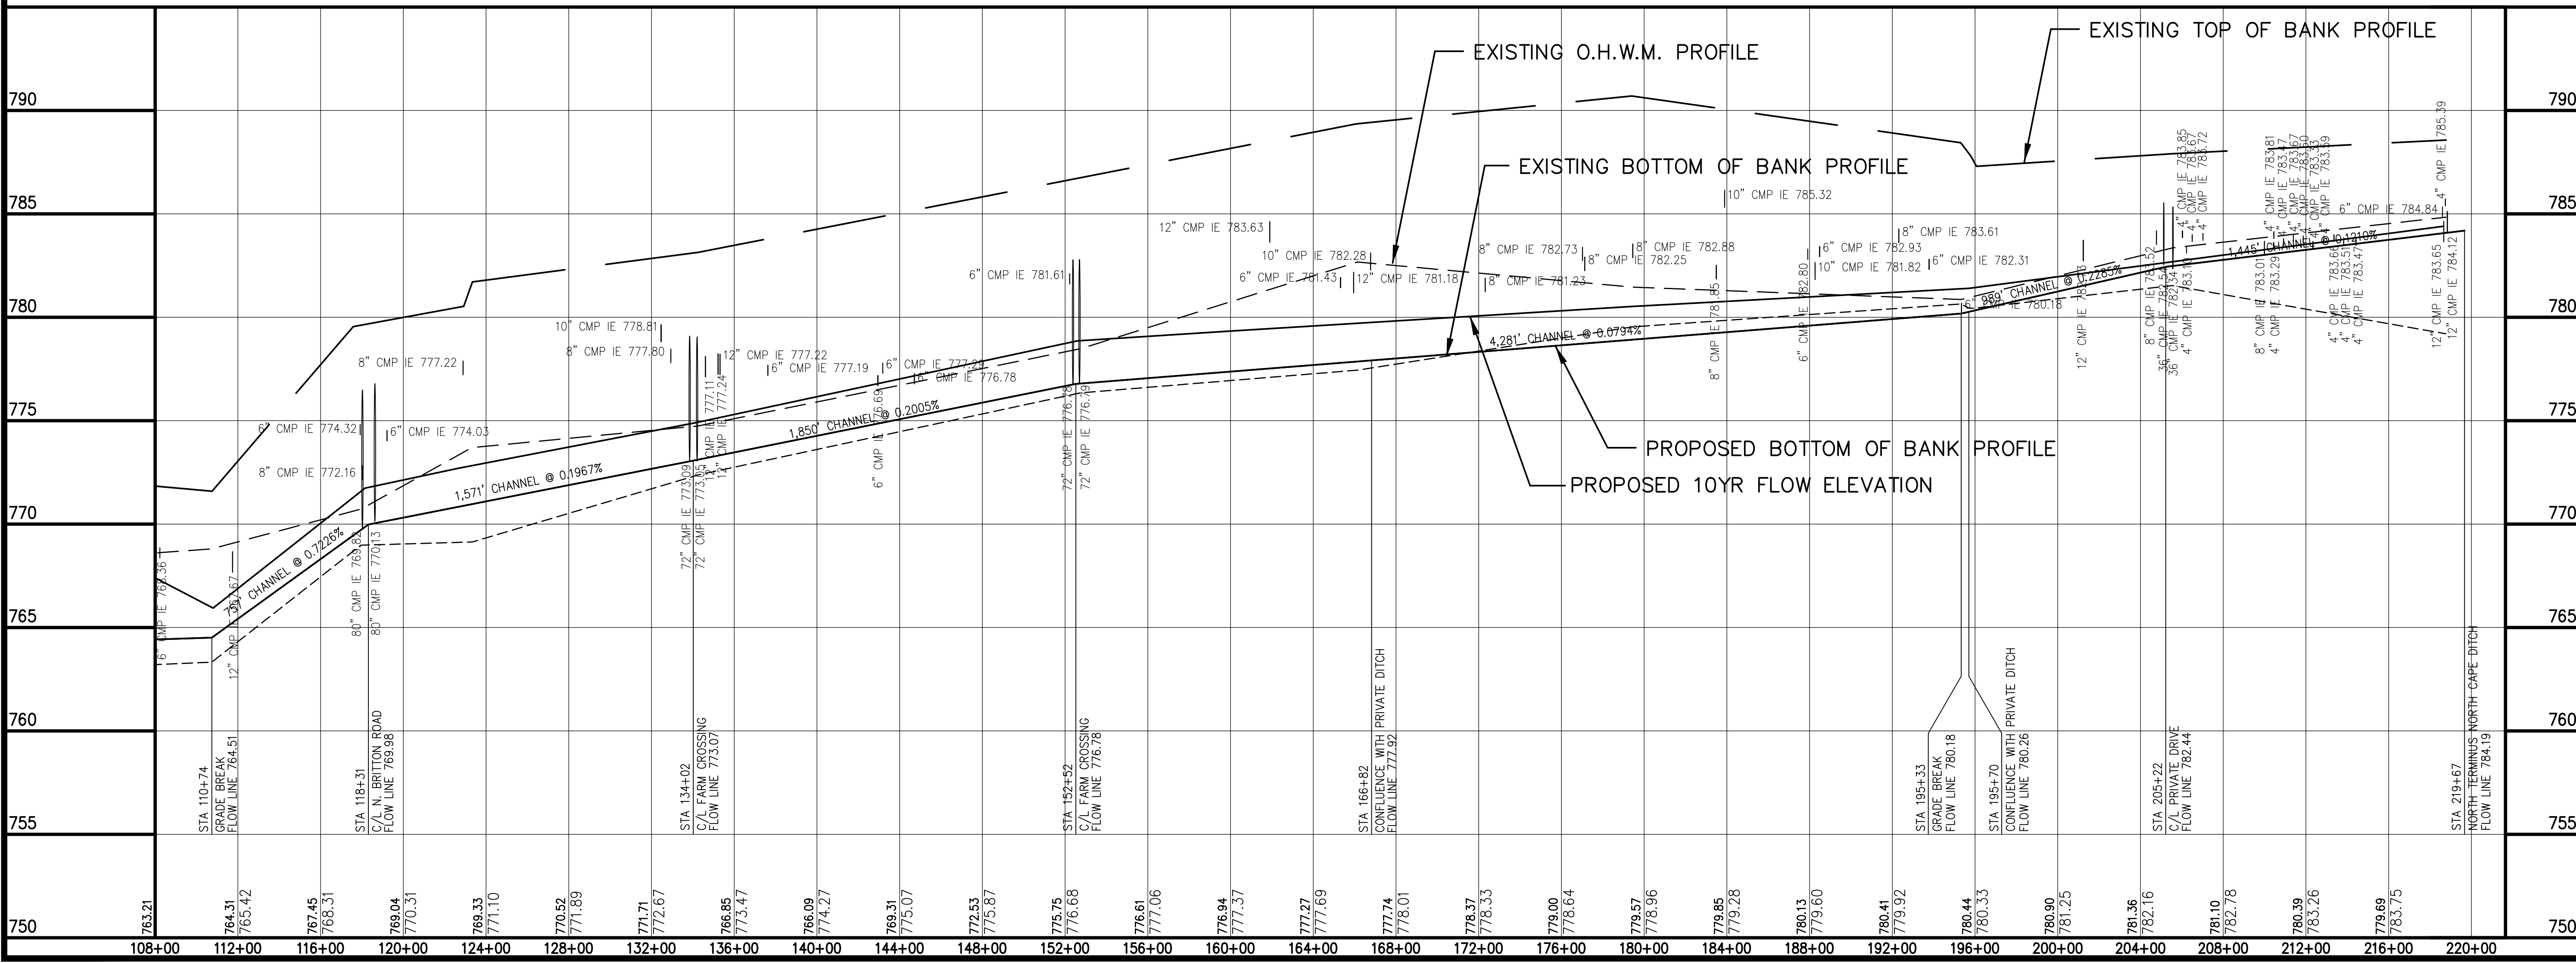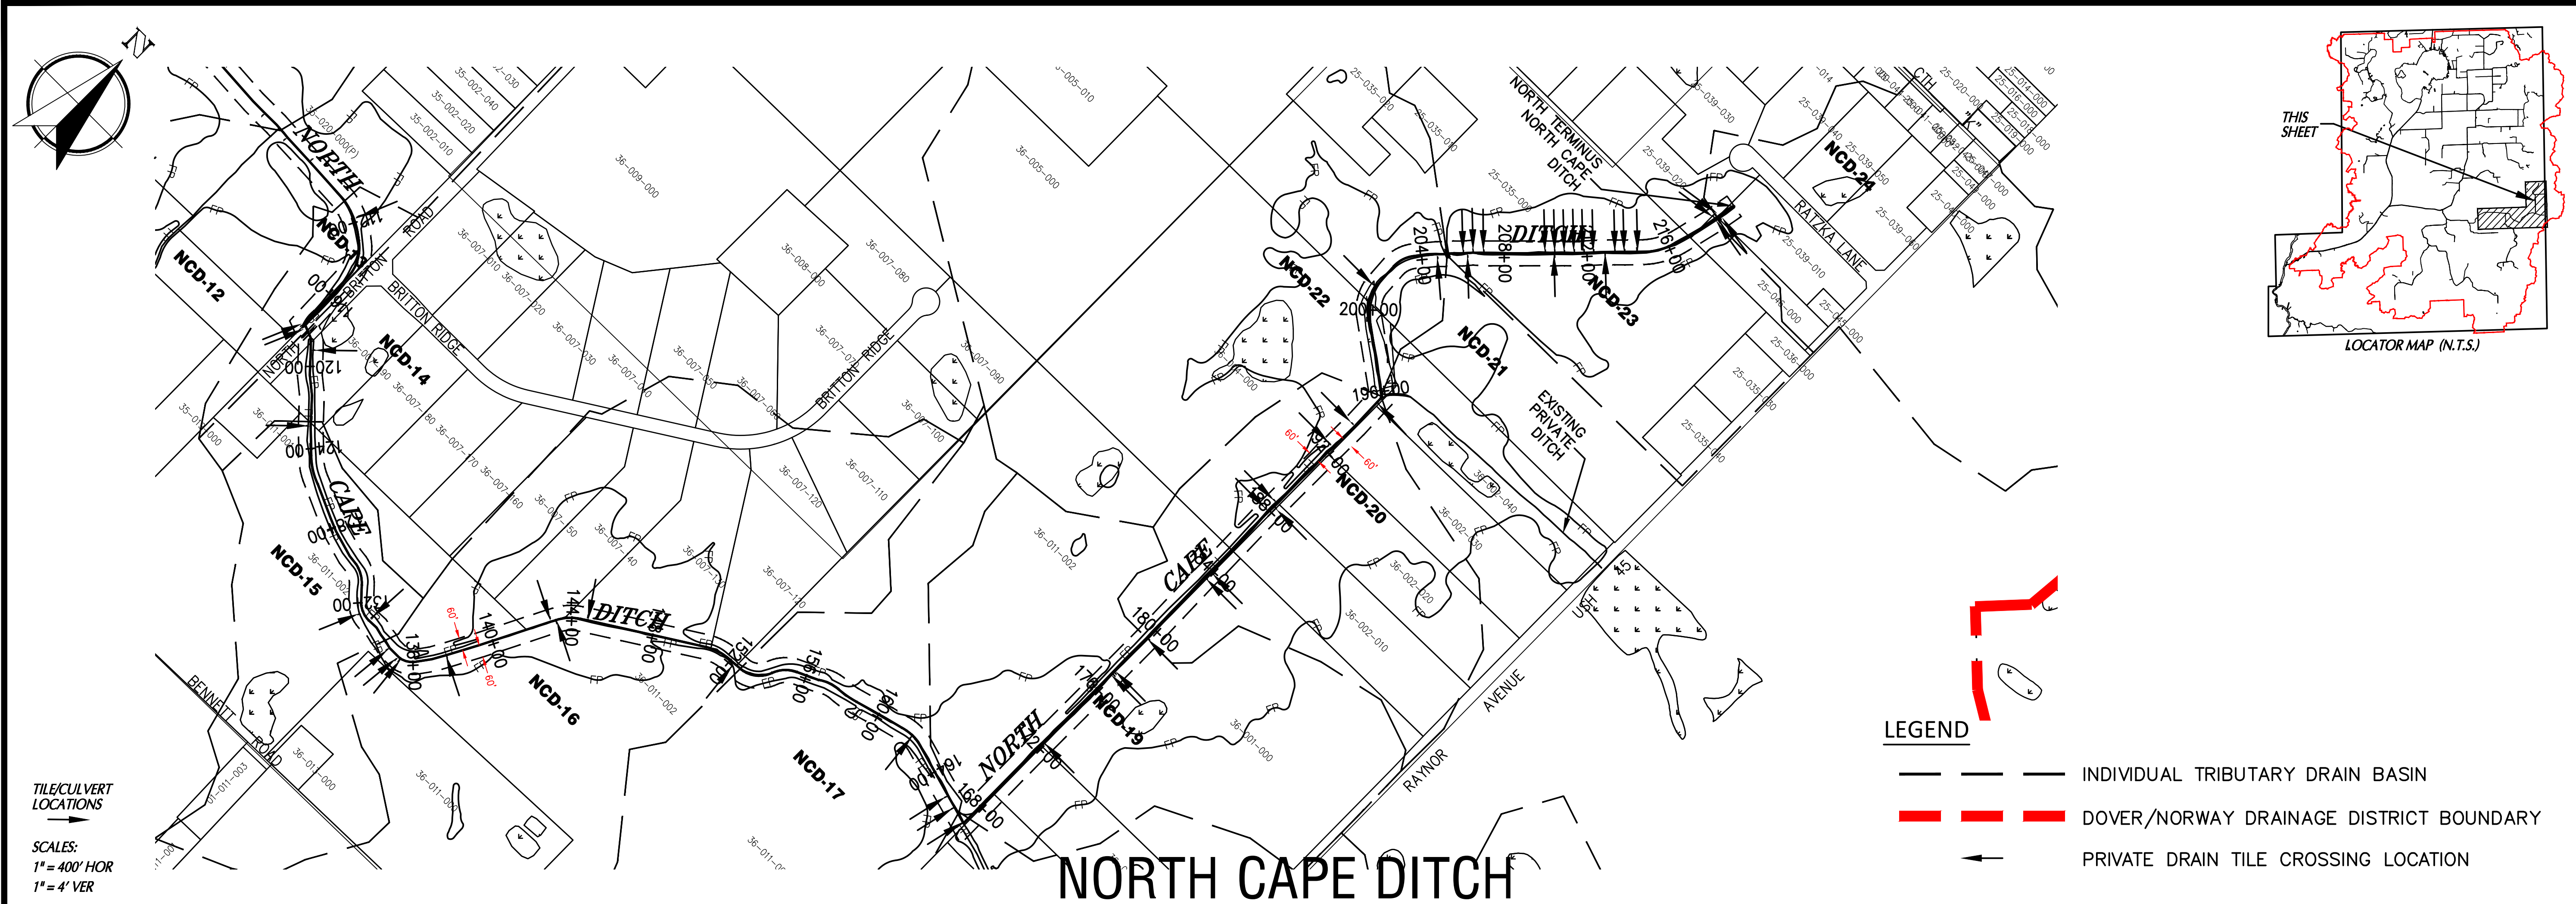

Thursday, June 13, 2024 8:46:10 AM

mb
 Nielsen Madsen & Barber S.C.
 Civil Engineers and Land Surveyors
 1339 Washington Ave. Racine, WI. 53403
 Tel: (262)634-5588 Fax: (262)634-5024
 Website www.nmbssc.net

DOVER / NORWAY DRAINAGE DISTRICT MAPPING
NORTH CAPE DITCH PLAN AND PROFILE
 RACINE WISCONSIN

NO.	REVISION	BY	DATE
1	REVISE ARROW DIRECTION TO REFLECT FLOW	SCB	11-18-10
2	UPDATE DISTRICT CORRIDORS	SCB	06-13-24

PROJ. MGR:	JMR
DRAFTED:	SCB
DATE:	6-16-2010
CHECKED:	JCB
DATE:	6-15-2010

2010.0022.01
 SHEET
26 OF 83